
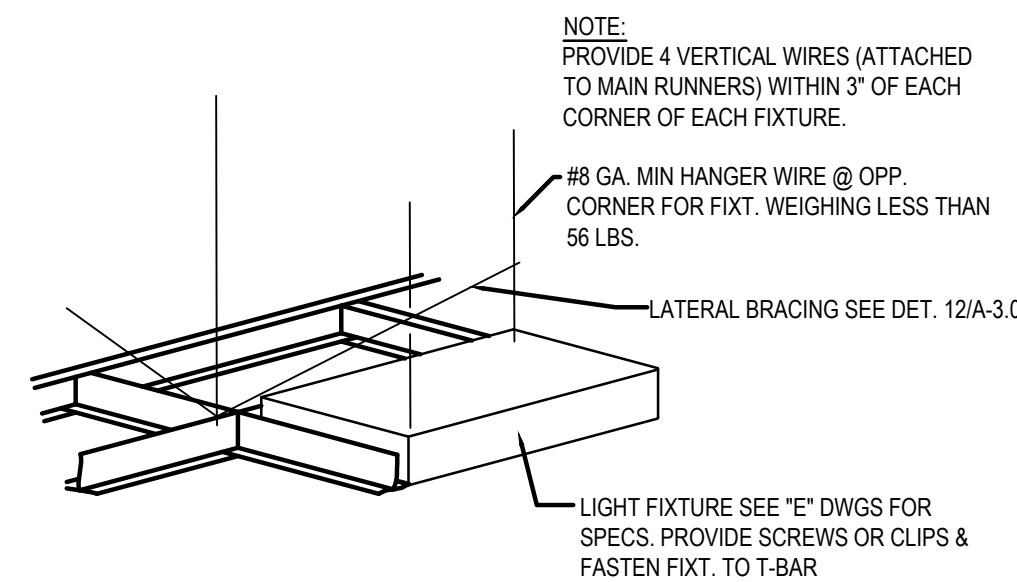
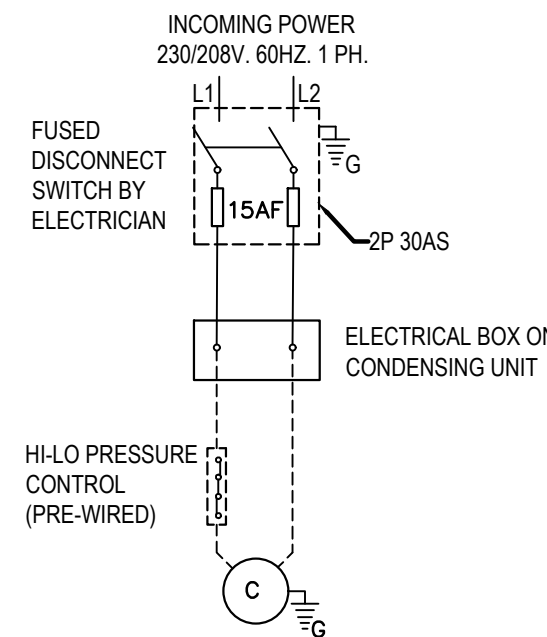


FIRE SUPPRESSION SHUTDOWN	13
NOT TO SCALE	E-400

SEQUENCE OF OPERATION		
TIME CLOCK	DESCRIPTION	TIME & STATUS
A	SIGNS	ON 5PM & OFF AT 10:30PM**
B	INSIDE LIGHTS	ON AT 9AM & OFF AT 11:30PM**
NOTES: ** PRIOR TO PROGRAMING THE TIME CLOCK COORDINATE THE TIME WITH THE OWNER.		

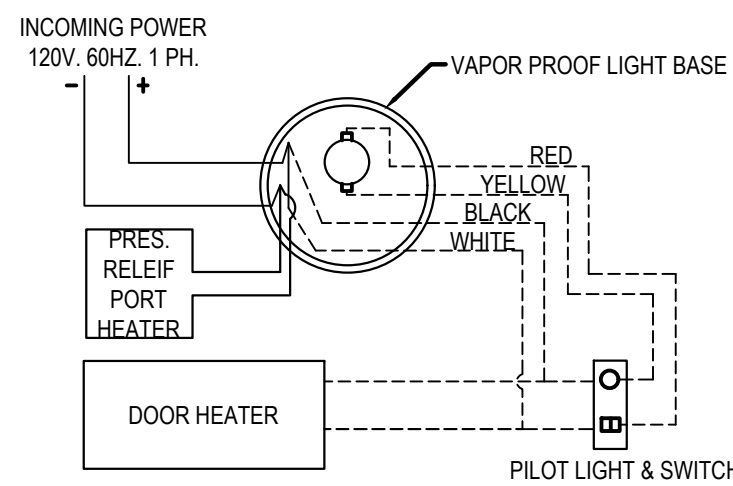


LIGHT FIXTURE DETAIL	4
NOT TO SCALE	E-400


DEVICE ORIENTATION		
X INCORRECT	X INCORRECT	✓ CORRECT
DEVICE & COVERPLATE COLOR		
LOCATION	DEVICE COLOR	COVER PLATE COLOR
DINING ROOM (WALLS)	VERIFY W/PX	VERIFY W/PX
DINING ROOM (IN BULKHEAD ABOVE WINDOW/)	VERIFY W/PX	VERIFY W/PX
DINING ROOM (WHEN IN CEILING)	BLACK	BLACK
RESTROOM	GREY	STAINLESS STEEL
RESTROOM VESTIBULE	GREY	STAINLESS STEEL
KITCHEN/SERVICE AREAS	GREY	STAINLESS STEEL
		VERIFY WITH PANDA PM PRIOR TO PURCHASE AND INSTALL.
		VERIFY WITH PANDA PM PRIOR TO PURCHASE AND INSTALL.
		@ SHOW WINDOW IN DARK CEILING (IF APPLICABLE)

SEQUENCE OF OPERATION	14
NOT TO SCALE	E-400


- KEY NOTES:
- 1 PROVIDE AN OVERRIDE SWITCH TO OVERRIDE THE TIME CLOCK DURING AFTER-HOURS WORK TO TURN ON THE LIGHTS NOT MORE THAN 2 HOURS ACCORDING WITH ENERGY CODE 2017 FBC C405.2.2.1.
 - 2 TIME CLOCK SHALL COMPLIED WITH FBC 2017 ENERGY CONSERVATION CODE C405.2.2.1.:
 - MINIMUM OF 7 DAY CLOCK
 - CAPABLE OF BEING SET FOR SEVEN "7" DIFFERENT DAY TYPES PER WEEK.
 - HOLIDAY "SHUTOFF"
 - PROGRAM BACK UP CAPABILITY AT LEAST 10H
 - OVERRIDE SWITCH
 - 3 FOR SEQUENCE OF OPERATION SEE SHEET E-400 / 14.
 - 4 CONTRACTOR TO PROVIDE EVIDENCE THAT THE LIGHTING CONTROL SYSTEM IS WORKING PROPERLY ACCORDING TO FBC C408.3 LIGHTING SYSTEM FUNCTIONAL TESTING.(TYPICAL)
- NOTE:
FOR MORE DETAIL REFER TO FBC 2017 ENERGY CONSERVATION.

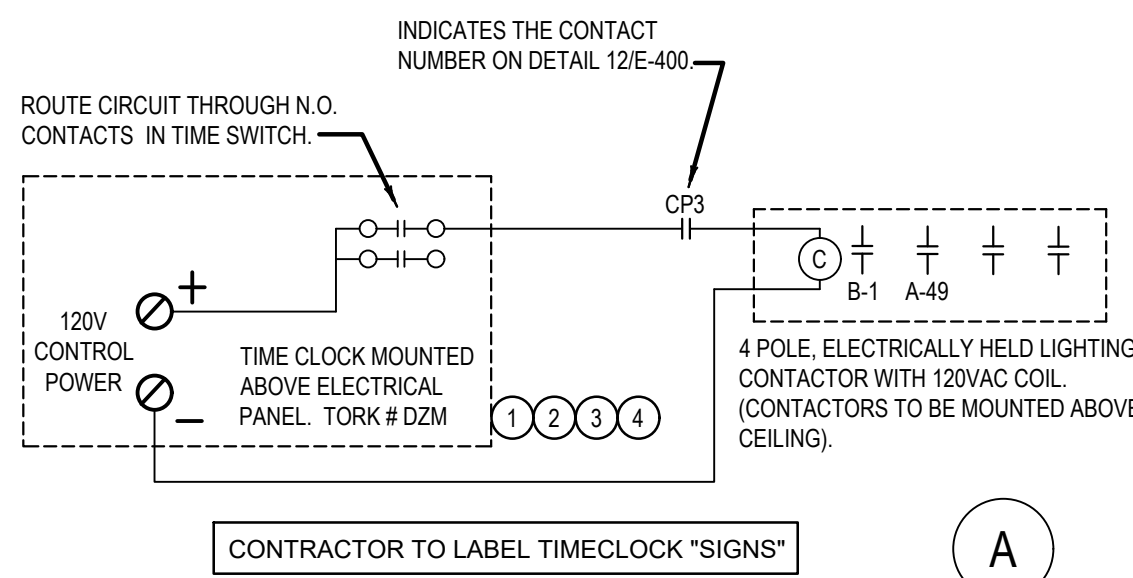

FREEZER LTG & DOOR HTR WIRING DIAGRAM	10
NOT TO SCALE	E-400

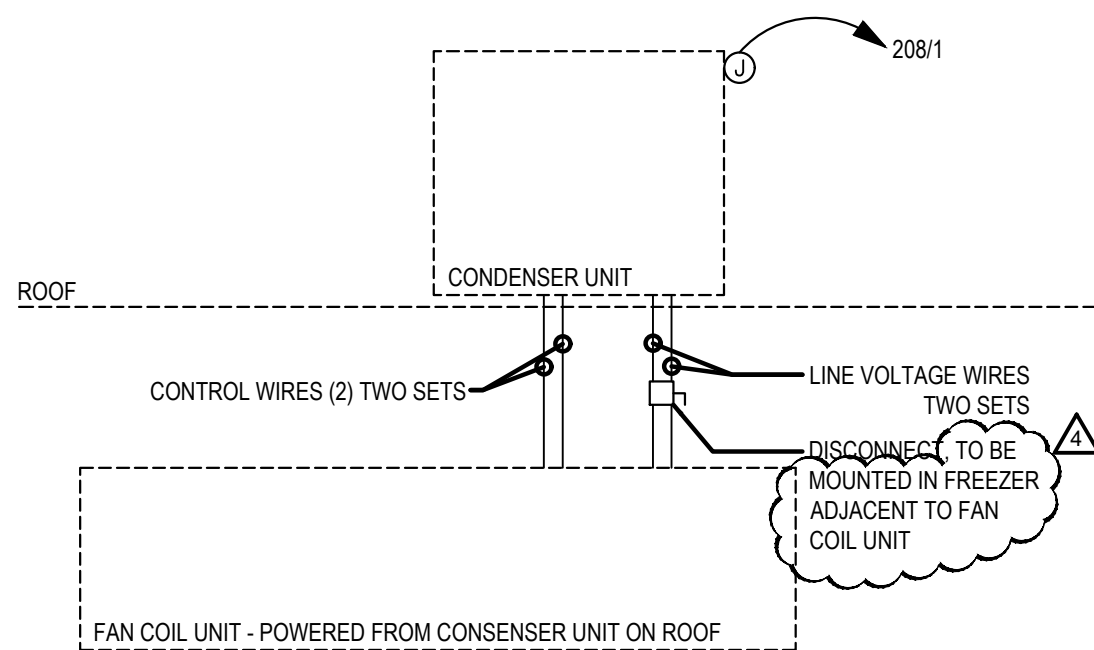





1. WIRING SHOULD BE DONE ACCORDING WITH NATIONAL AND LOCAL CODE.
2. CHECK VOLTAGE ON CONDENSING UNIT AND EVAPORATOR COIL BEFORE ANY WORK IS DONE.
3. SOLID LINES TO BE WIRED BY LICENSED ELECTRICIAN ON SITE. DOTTED LINES ARE MANUFACTURE PRE-WIRED.
4. ANY PENETRATIONS THROUGH BOX SHALL BE SEALED AIR TIGHT.

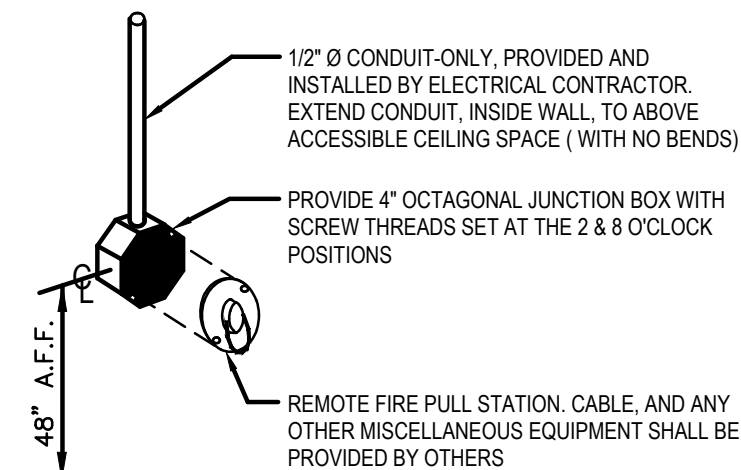

FREEZER EVAPORATOR COIL	9
NOT TO SCALE	E-400

WIC / WIF WIRING DIAGRAM NOTES	6
NOT TO SCALE	E-400

ANSUL PULL STATION DETAIL	2
NOT TO SCALE	E-400

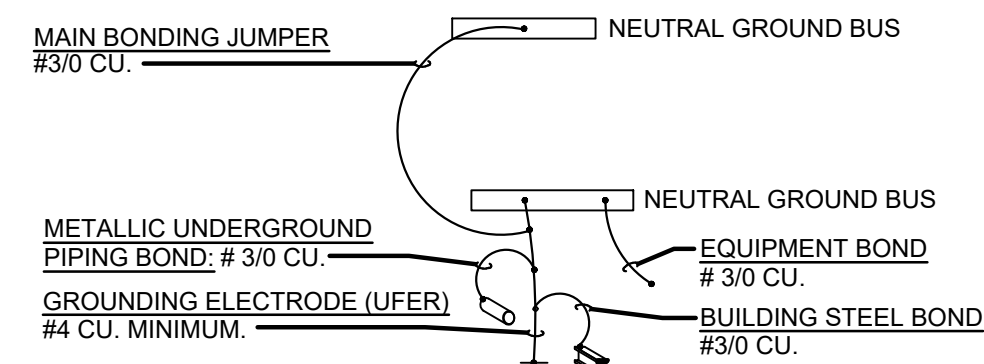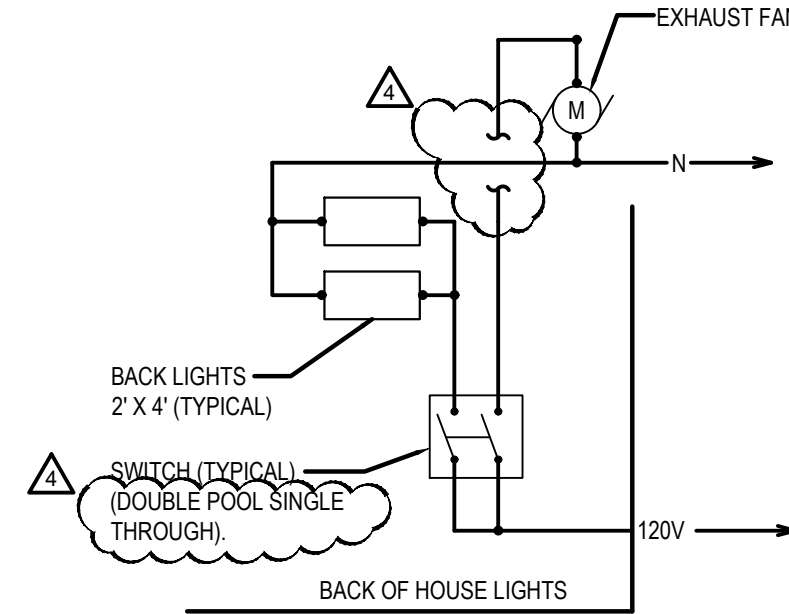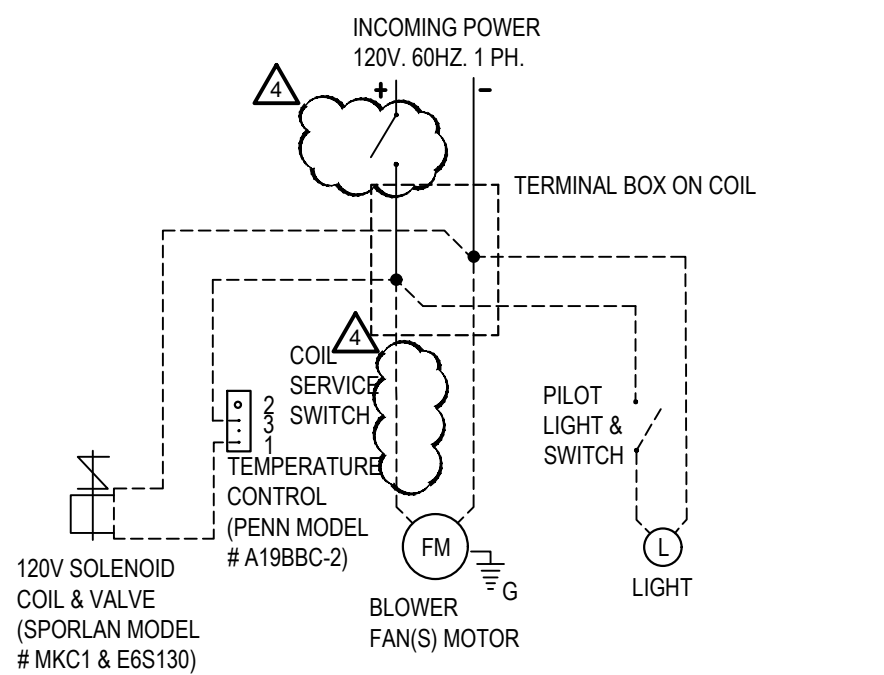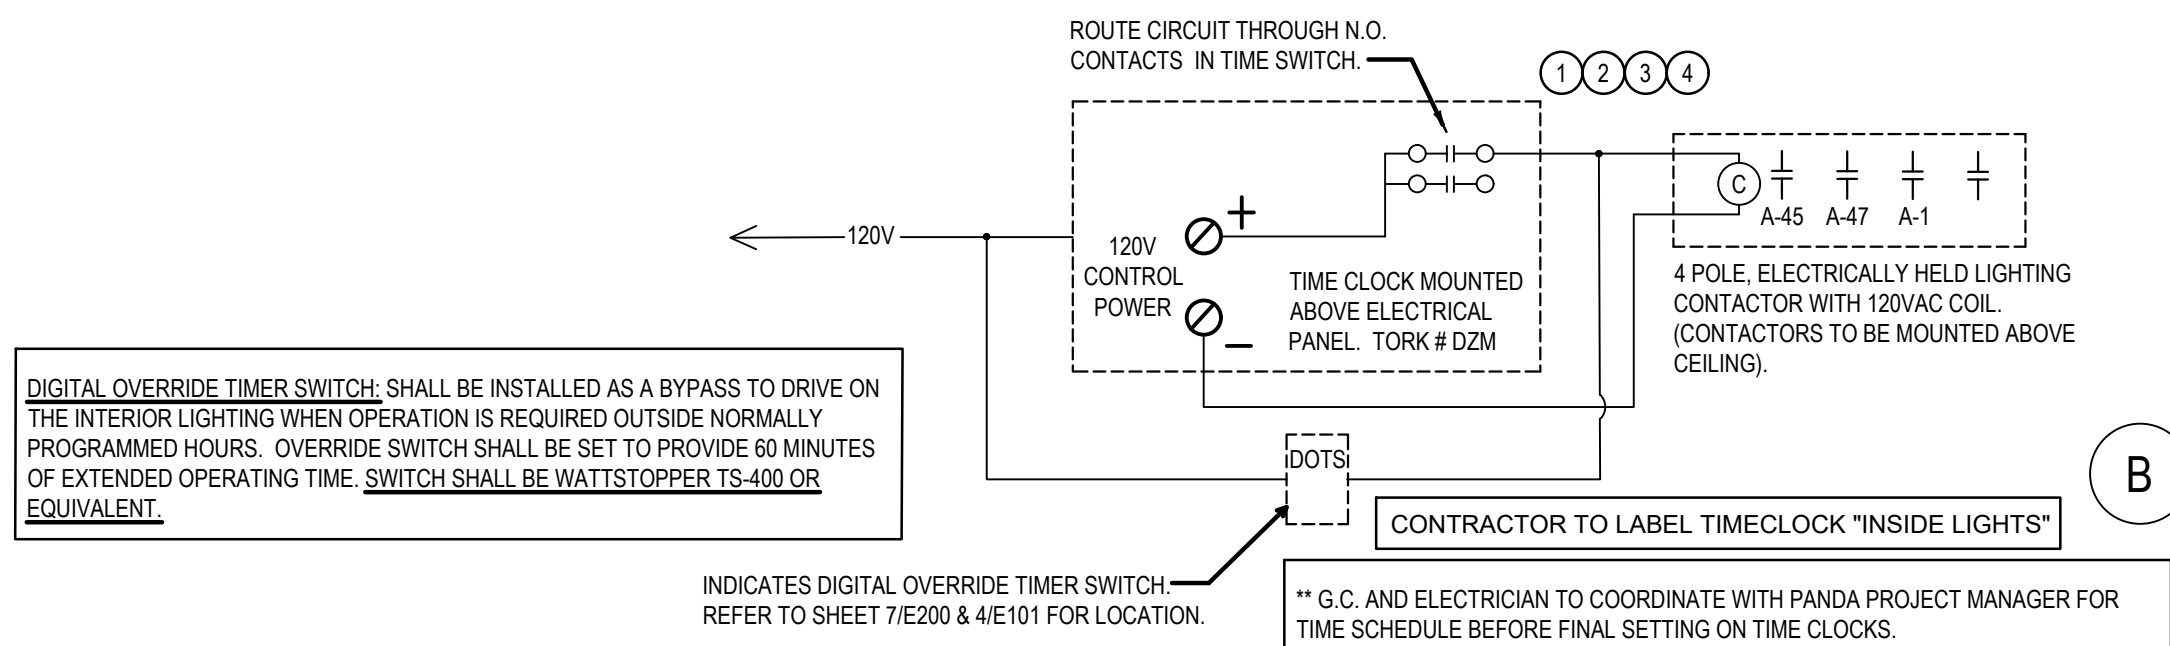

TIME CLOCKS	11
NOT TO SCALE	E-400

COOLER EVAPORATOR COIL	8
NOT TO SCALE	E-400

EXHAUST FAN CONTROL DIAGRAM	5
NOT TO SCALE	E-400

"SE" DISC. GROUNDING DETAIL	1
NOT TO SCALE	E-400



PANDA RESTAURANT GROUP INC.
1683 Walnut Grove Ave.
Rosemead, California
91770
Telephone: 626.799.9898
Facsimile: 626.372.8288


All ideas, designs, arrangement and plans indicated or represented by this drawing are the property of Panda Express Inc. and were created for use on this specific project. None of these ideas, designs, arrangements or plans may be used by or disclosed to any person, firm, or corporation without the written permission of Panda Express Inc.

REVISIONS:
OWNER CHANGES 04-23-21

ISSUE DATE:
1 CHECK SET 06-18-19
2 PERMIT SET 03-23-20
3 BID SET 01-04-21

DRAWN BY: EJP

PANDA PROJECT #: S4-19-D6240
ARCH PROJECT #: P7331

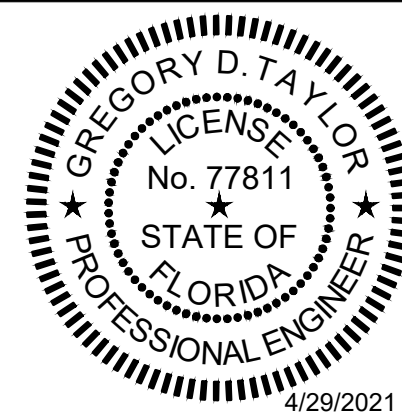

PANDA EXPRESS
END CAP - TENANT BUILD OUT
5750 NW 183RD ST
HIALEAH, FL 33015

E-400

ELECTRICAL DETAILS, DIAGRAMS